


DRAWN BY



GIBSON Mech Inc.  
151-58 7th Ave. Whitestone, N.Y 11357

HVAC SHOP DRAWINGS  
UBER GREENLIGHT HUB  
BRONX  
694 BURKE AVENUE  
BRONX, NY

KEY PLAN

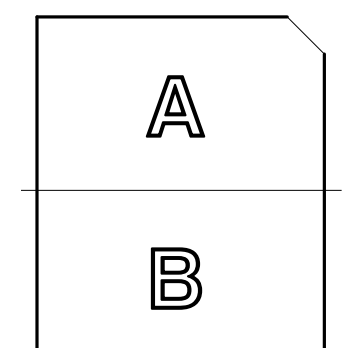

REVISIONS


NO.	DATE	DESCRIPTION
1	7/30/19	ISSUE
2	8/8/19	ELEVATION CHANGES

HVAC SHOP  
DRAWINGS

MECHANICAL 3D VIEW

SD000

1 2 3 4 5

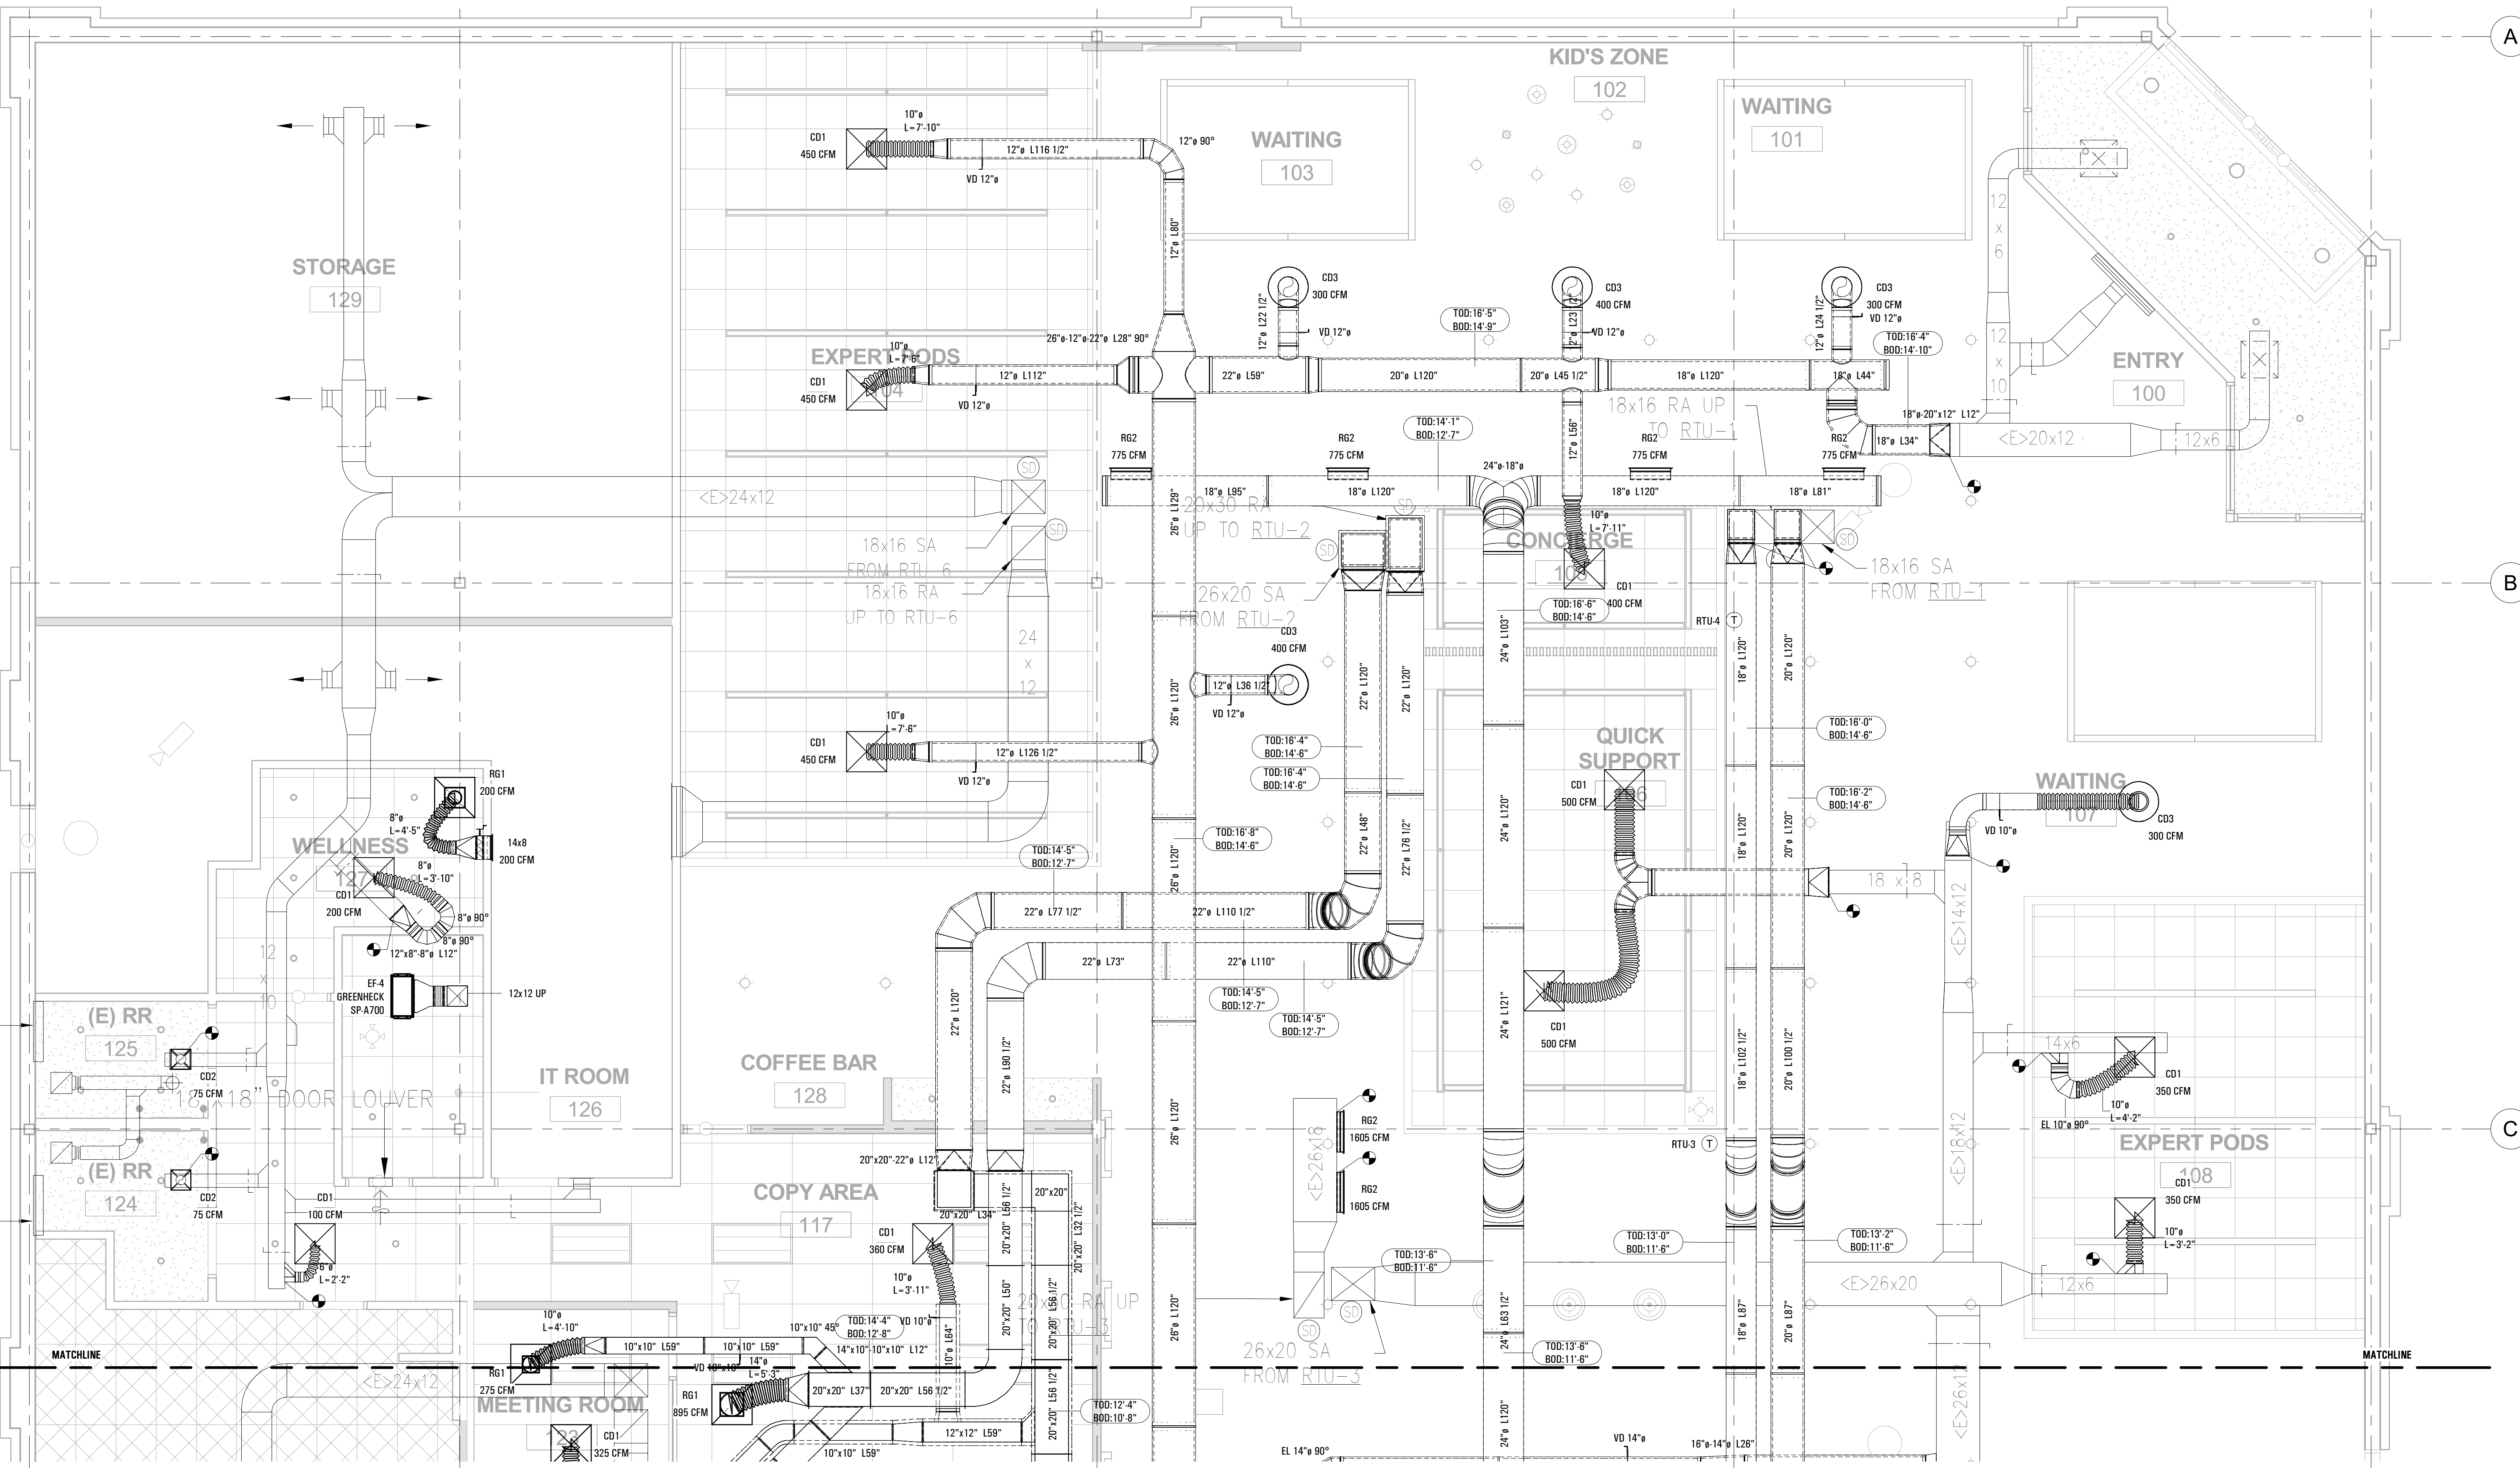


A  
B  
C

1 FIRST FLOOR - A  
1/4" = 1'-0"

DRAWN BY  
GIBSON MECH INC.  
SHEET METAL  
GIBSON Mech Inc.  
151-59 7th Ave. Whitestone, N.Y 11357

HVAC SHOP DRAWINGS  
UBER GREENLIGHT HUB  
BRONX  
694 BURKE AVENUE  
BRONX, NY

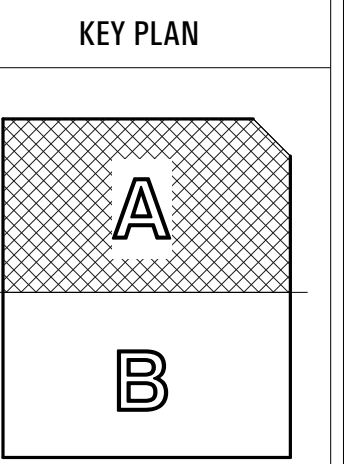


REVISIONS

1	7/30/19	ISSUE
2	8/8/19	ELEVATION CHANGES

HVAC SHOP DRAWINGS  
FIRST FLOOR PLAN A

SD001

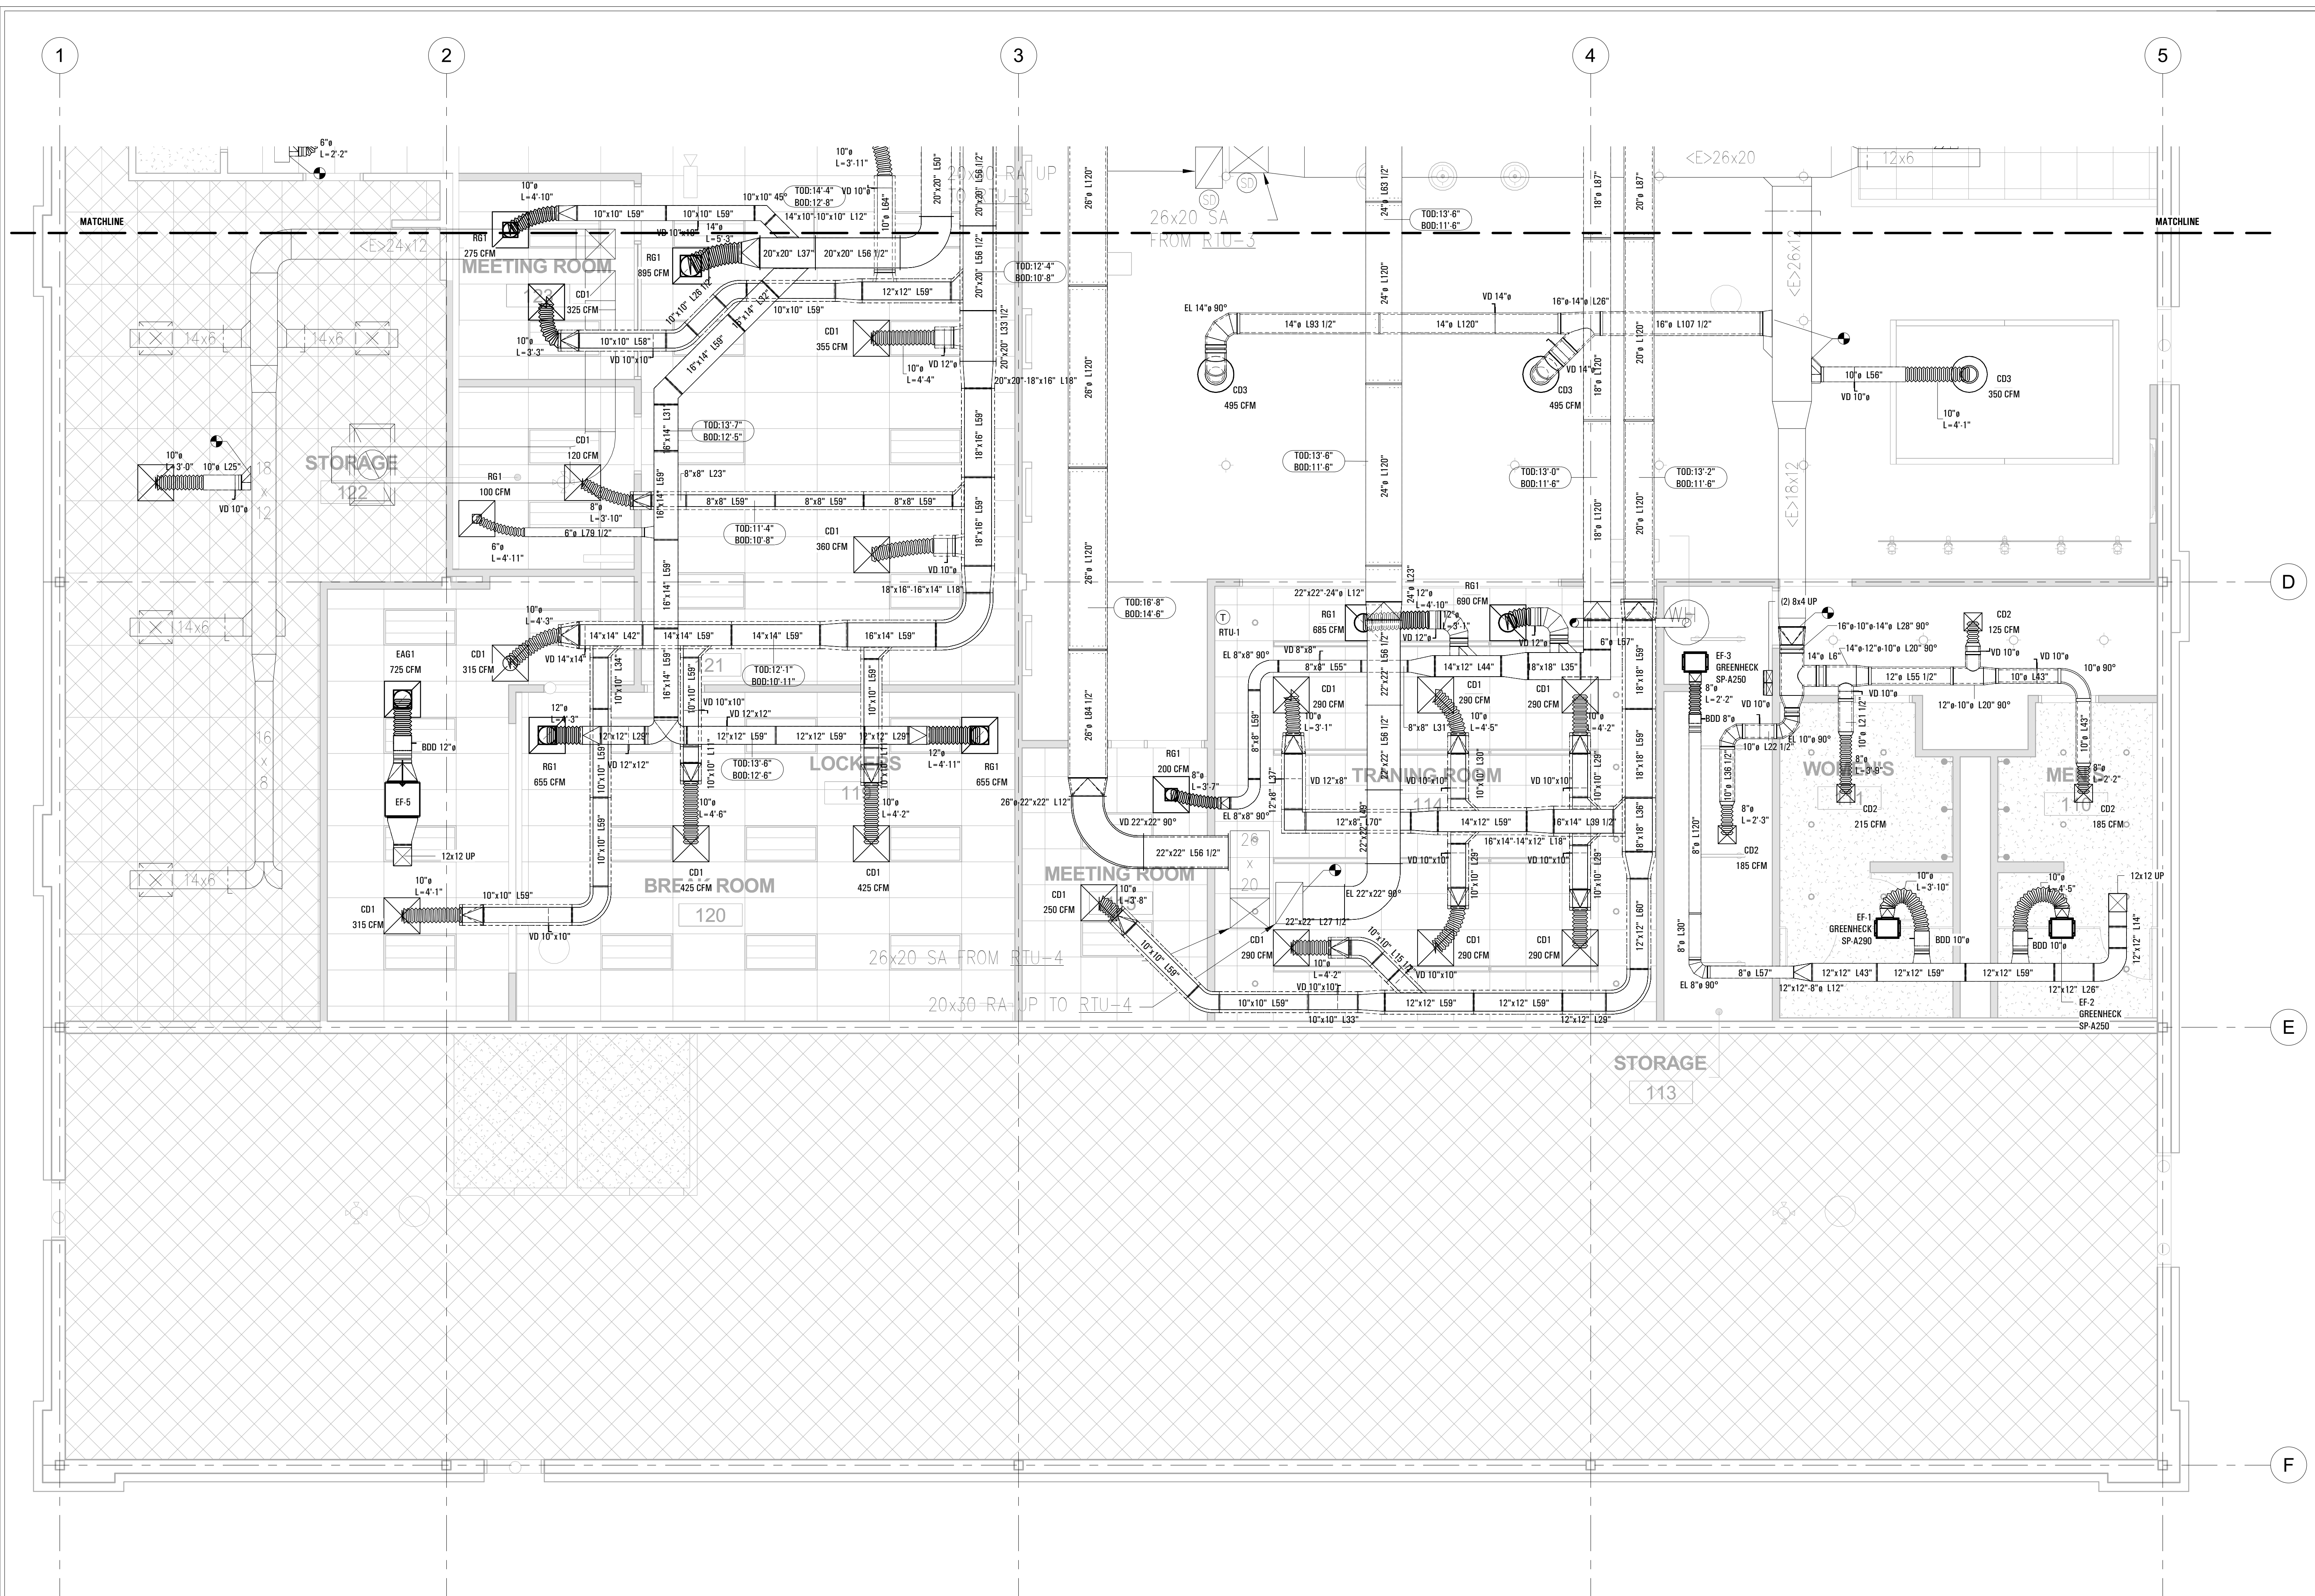


1 FIRST FLOOR - B  
1/4" = 1'-0"

DRAWN BY

GIBSON Mech Inc.  
151-58 7th Ave. Whitestone, N.Y 11357

HVAC SHOP DRAWINGS  
UBER GREENLIGHT HUB  
BRONX  
694 BURKE AVENUE  
BRONX, NY

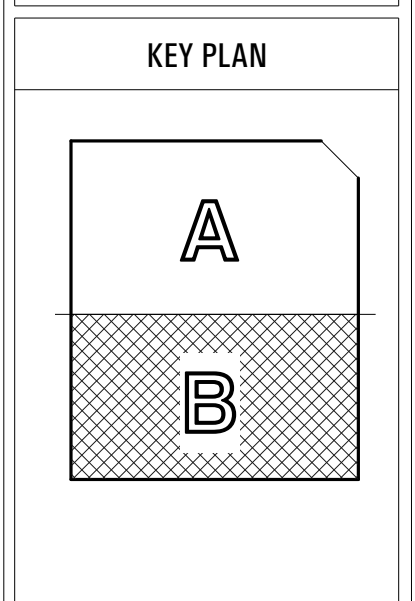

REVISIONS

1	7/30/19	ISSUE
2	8/8/19	ELEVATION CHANGES

HVAC SHOP DRAWINGS  
FIRST FLOOR PLAN B

SD002